



**MTES**  
ENGINEERING SERVICES  
11091 Molly Pitcher Circle  
Manassas, Virginia 20109  
Telephone: (703) 606-3386  
MTESeng@outlook.com

**2MH Consulting Engineers**  
Land Development Services  
10046 Cabin Ridge Court  
Manassas, Virginia 20110  
Telephone: (703) 725-7113


**CIVIL ENGINEERING PLAN FOR  
2415 SHIRLINGTON ROAD - BY RIGHT**

2415 & 2411 SHIRLINGTON ROAD ARLINGTON, VIRGINIA 22206

PARCEL NUMBERS 31-025-008 & 31-025-009  
ARLINGTON COUNTY, VIRGINIA

**MISS UTILITY**  
48 HOURS BEFORE YOU DIG  
CALL "MISS UTILITY" AT 811 OR 800-552-7001  
OR LOG ON TO va811.com

PLAN STATUS	
12/09/2022	1ST SUBMISSION
04/11/2023	2ND SUBMISSION
10/18/2023	3RD SUBMISSION
DATE	DESCRIPTION
SCALE:	1"=20'
PLAN DATE:	12/9/2022
PLAN NO.:	CEPL22-00138
SWM PLAN NO.:	SWM 23-0004
DESIGNED BY:	MH
2MHC PROJECT NO.:	20220006

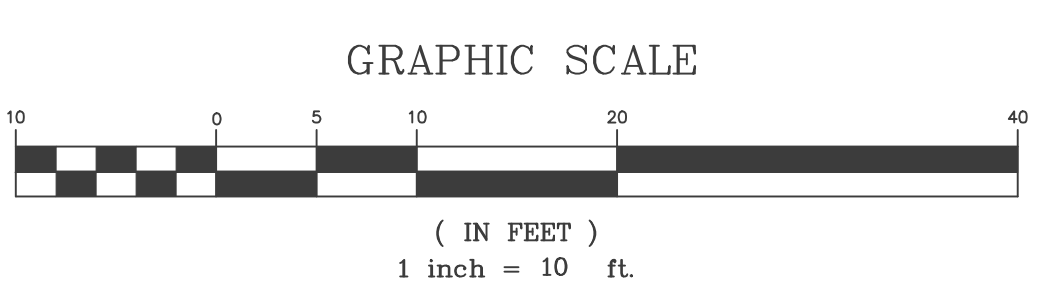

**GRADING PLAN**

SHEET NAME  
GRADING PLAN

SHEET #  
**C008**

